
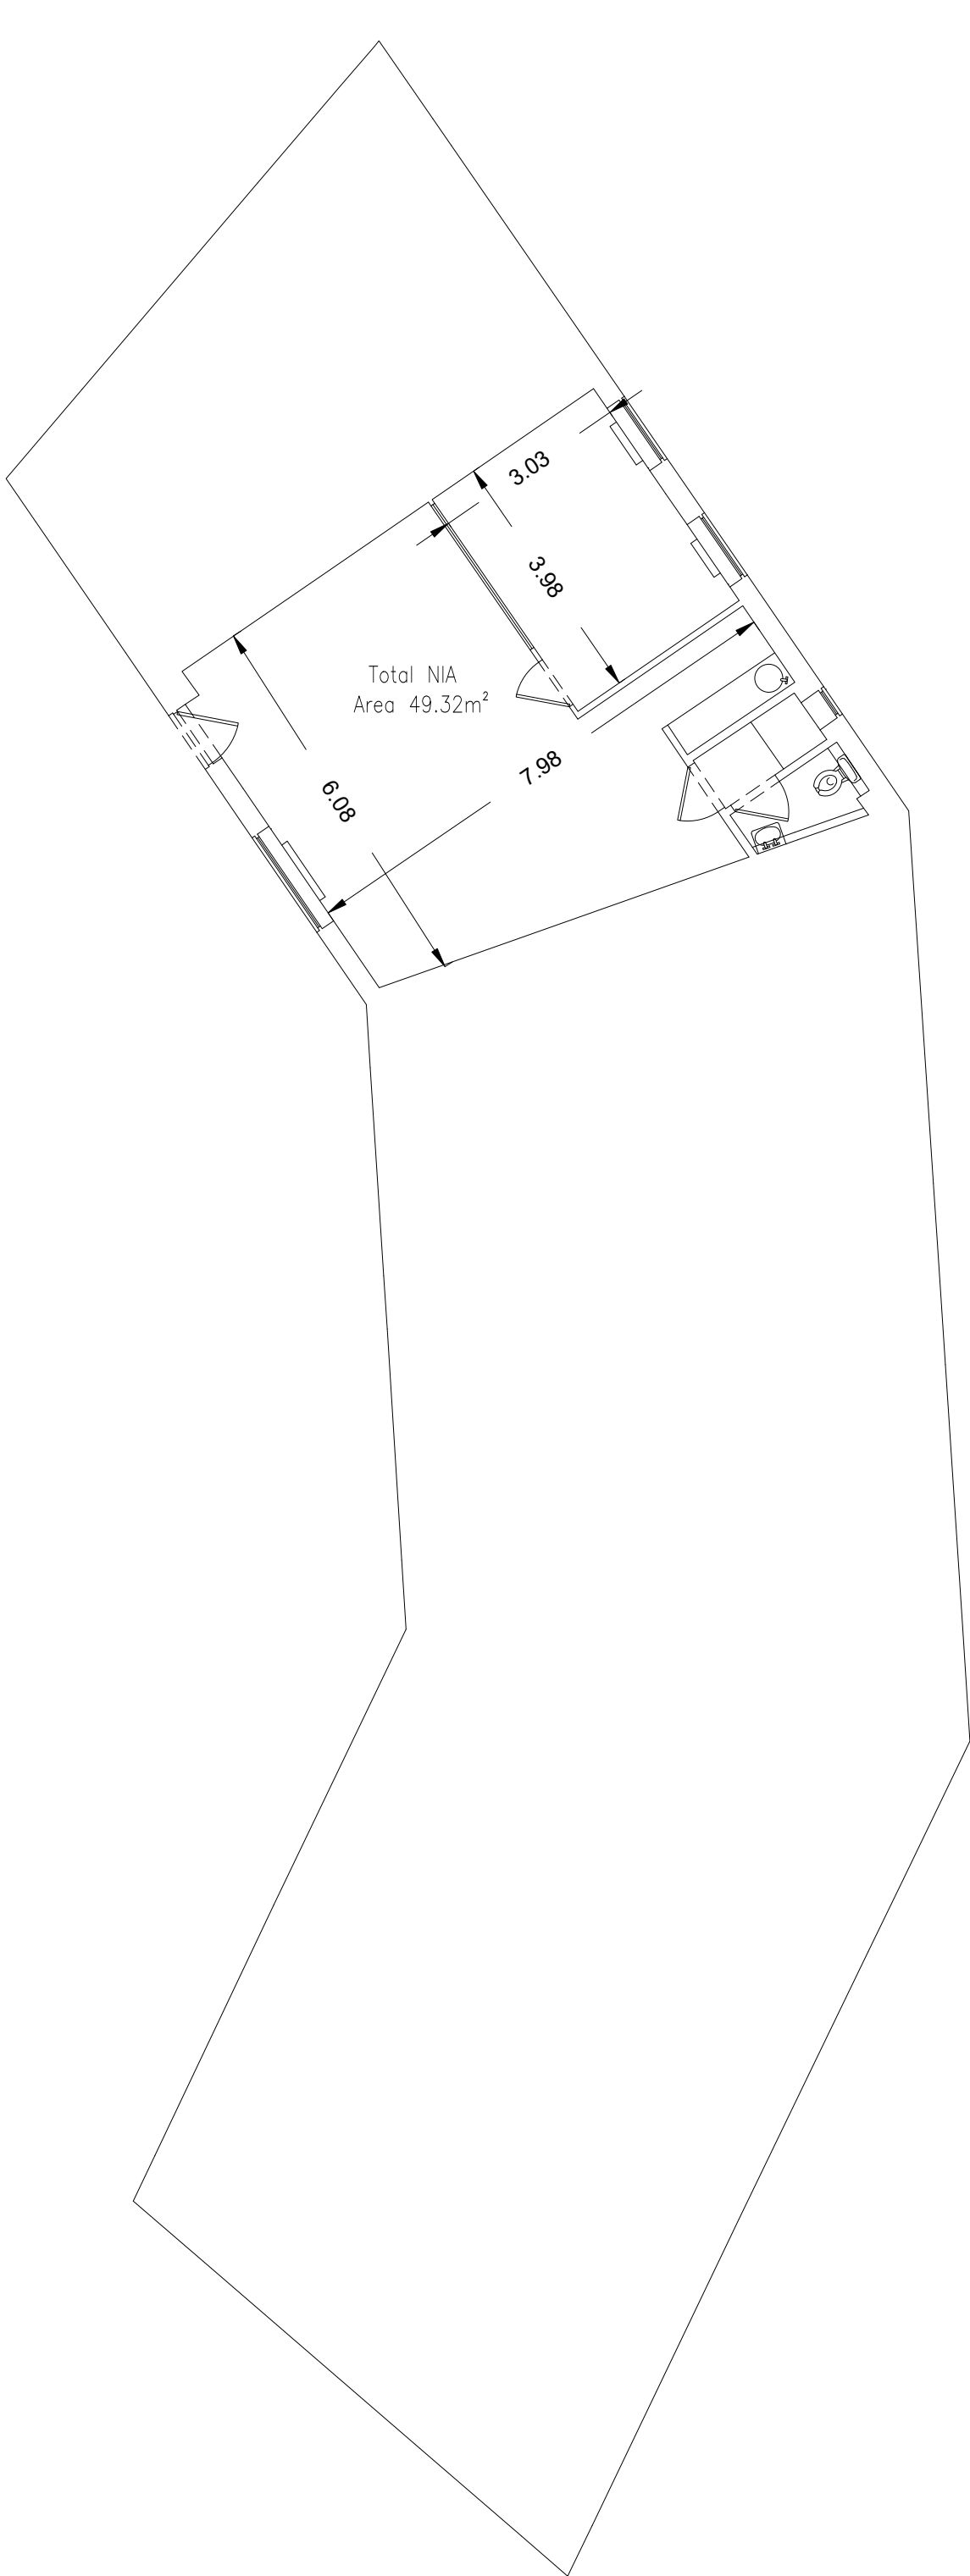



Legend:			
Abbreviated Features:	Symbols:		
AB Air Brick	LI Light	Radiator	RA
B Balcony	LI Light	Light	LI
C/B Close Boarded	P Post	Emergency Light	EL
C-H Cill to Head	P/C Pitched Ceiling	Strip Light	SL
C/L Chain Link	PE Pipe	Wall Mounted Light	WML
CL Ceiling Level	P/R Pitched Roof	Mains Point	MP
CPD Cupboard	P/W Point & Wire	Blank Plate	BP
CR Crown Point Level	RD Roller Door	Light Switch	LS
DH Door Height	RNP Rainwater Pipe	Pendant Switch	PS
Dr Drain	SD Sliding Doors	Isolator Switch	IS
FE Fire Exit	SC Suspended Ceiling Level	Alarm Bell	AB
F-C Floor to Cill	SP Spring Point Level	Fire Alarm Push	FAP
FL Floor Level	SW Soil & Vent Pipe	Snow Detector	SD
FW Four Water	SW Surface Water	Alarm Panel	AP
MH Manhole	US Underside	Thermotat	TR
U Dully	UTL Underside To Lift	Modern	MD
IC Inspection Chamber	VP Vent Pipe	Fuse Box	FB
IL Invert Level	VI Vent	Electric Box	EB
I/R Iron Railings		Heater	HT
		Water Stop Tap	WST
		Overhead Features	-----

Plan Coordinate Control:--
N/A
Level Datum:--
All Levels relate to OSGB36 using GPS

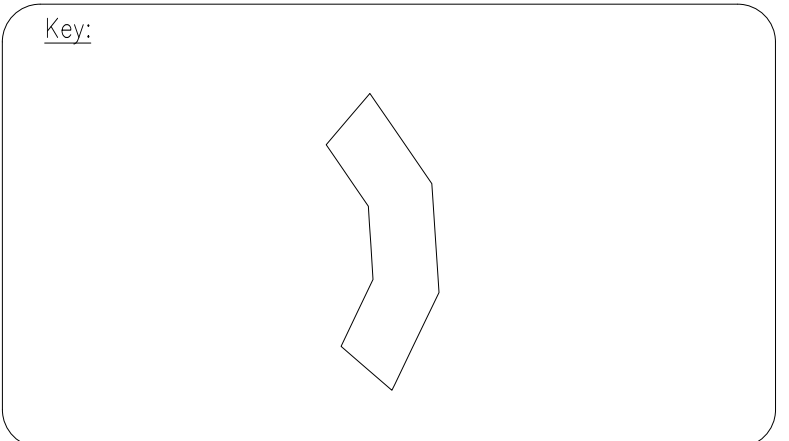

Notes:

REV A	Areas & Dimensions added	07/03/25	SJH
REV NO	REV NOTE	DATE	SIGNED

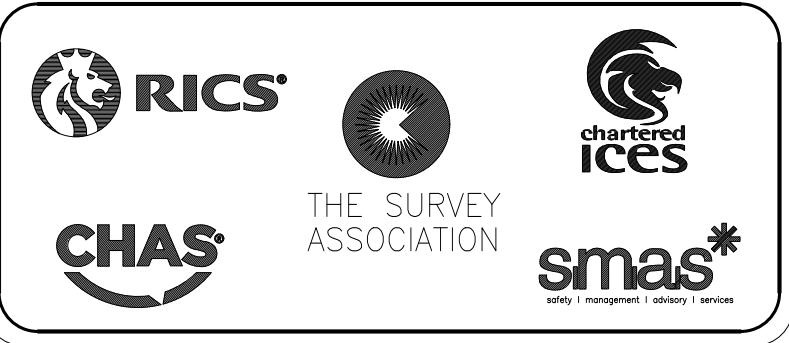

GLOBAL SURVEYS

3 Brookfield, Duncan Close,
Moulton Park, Northampton, NN3 6WL
Tel: 01604 491543
Email: info@globalsurveys.co.uk

Site:	Warren Park Wolverton Milton Keynes MK12 5NF
Client:	Milton Keynes Parks Trust
Survey Title:	Measured Building Survey 15 Canon Harnett Court Floor Plans

Date	February 2025	Scale	1/100 @ A1
Dwg No.	24708_15_CHC	Surveyor	KMG
Sheet	1 of 1	Checked	SJH