


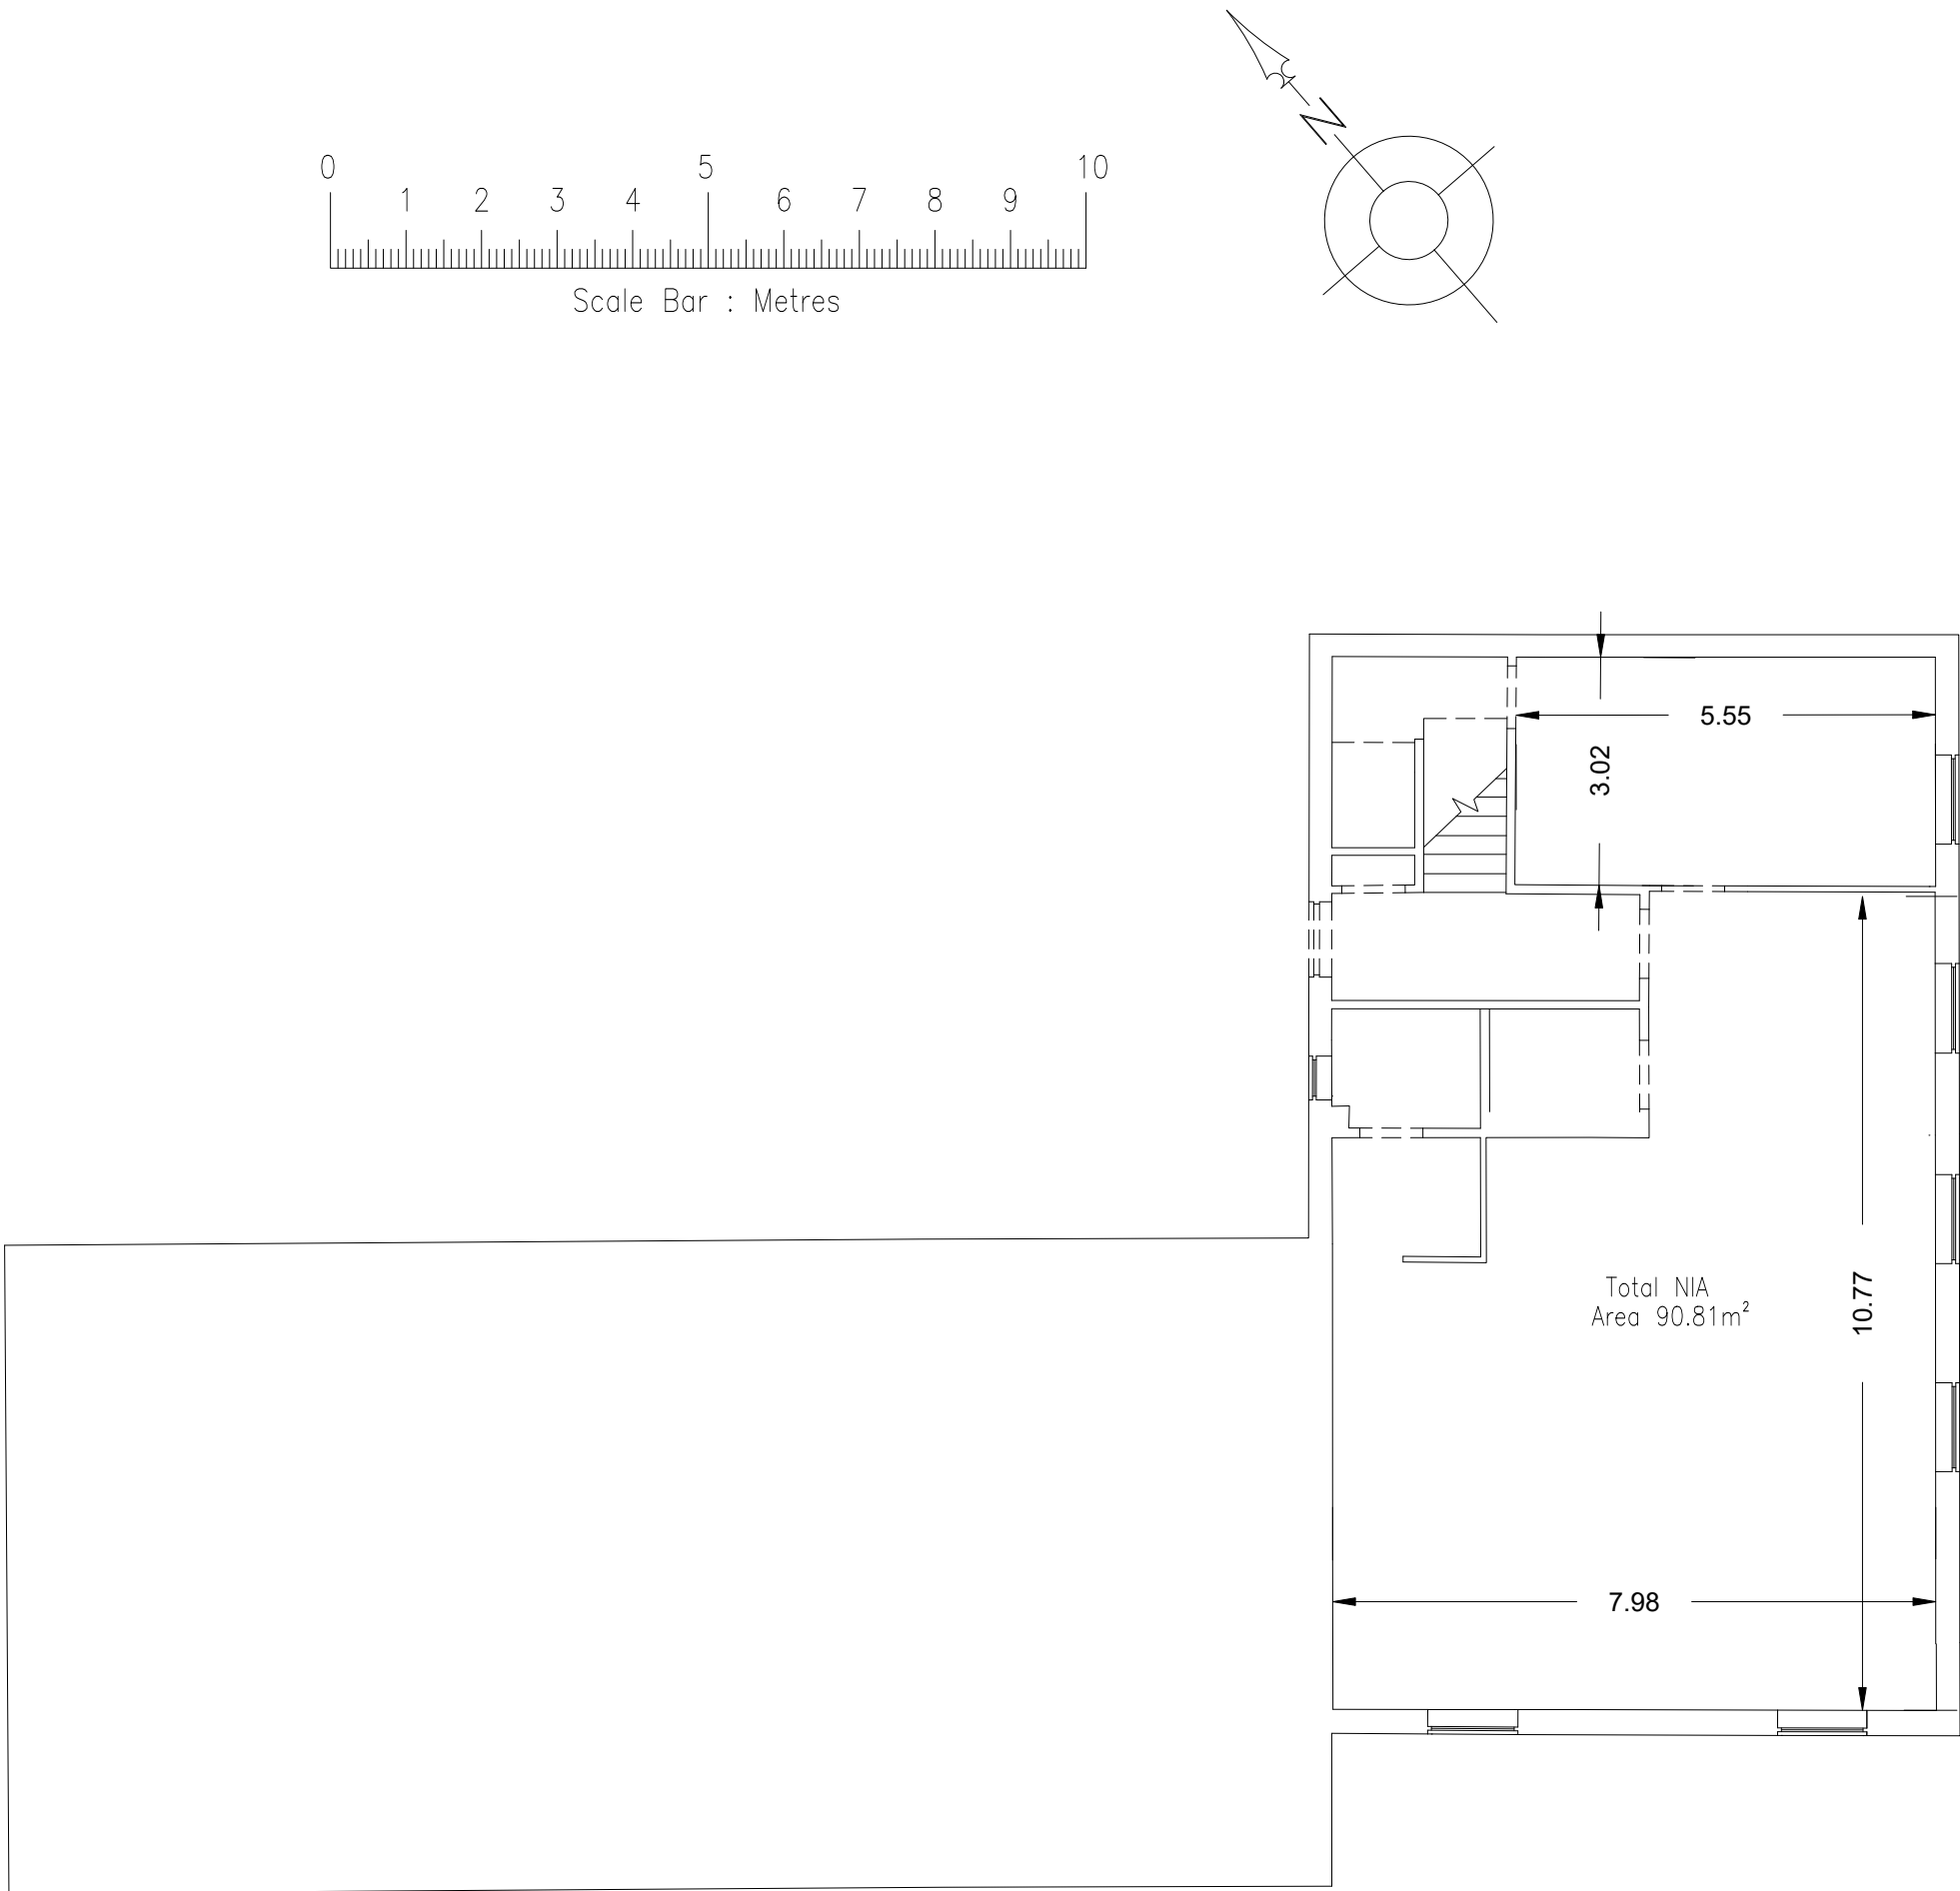

Legend:		
Abbreviated Features:	Symbols:	
AB Air Brick	LI Light	Radiator
B Ballard	D/F Overflow Pipe	Light
C/B Close Boarded	P Post	Emergency Light
C-H Cill to Head	P/C Pitched Ceiling	Strip Light
C/L Chain Link	PE Pipe	Wall Mounted Light
CL Ceiling Level	P/R Pitched Roof	Mains Point
CPD Cupboard	P/W Post & Wire	Blank Plate
CR Crown Point Level	RD Roller Door	Light Switch
DH Door Height	RE Rodding Eye	Pendant Switch
Dr Drain	RWP Rowerwater Pipe	Isolator Switch
FE Fire Exit	SD Sliding Doors	Alarm Bell
F-C Floor to Cill	SSL Suspended Ceiling Level	Fire Alarm Push
FL Floor Level	SP Spring Point Level	Snow Detector
FW Four Water	SV Soil & Vent Pipe	Alarm Panel
MH Manhole	SW Surface Water	Thermostat
U Underdrain	US Underdrain	Modern
IC Inspection Chamber	UTL Unclie To Lift	Fuse Box
IL Invert Level	VP Vent Pipe	Electric Box
I/R Iron Rollings	VI Vent	Heater
		Water Stop Tap
		Overhead Features -----

Plan Coordinate Control:--
N/A

Level Datum:--
All Levels relate to OSGB36 using GPS

Key:

Notes:

REV A	Areas & Dimensions added	07/03/25	SJH
REV NO	REV NOTE	DATE	SIGNED

3 Brookfield, Duncan Close,
Moulton Park, Northampton, NN3 6WL
Tel: 01604 491543
Email: info@globalsurveys.co.uk

Site: Warren Park
Wolverton
Milton Keynes MK12 5NF

Client: Milton Keynes Parks Trust

Survey Title: Measured Building Survey
1G Canon Harnett Court Floor Plans

Date	February 2025	Scale	1/100 @ A1
Dwg No.	24708_1G_CHC	Surveyor	KMG
Sheet	1 of 1	Checked	SJH