



GROUND FLOOR PLAN

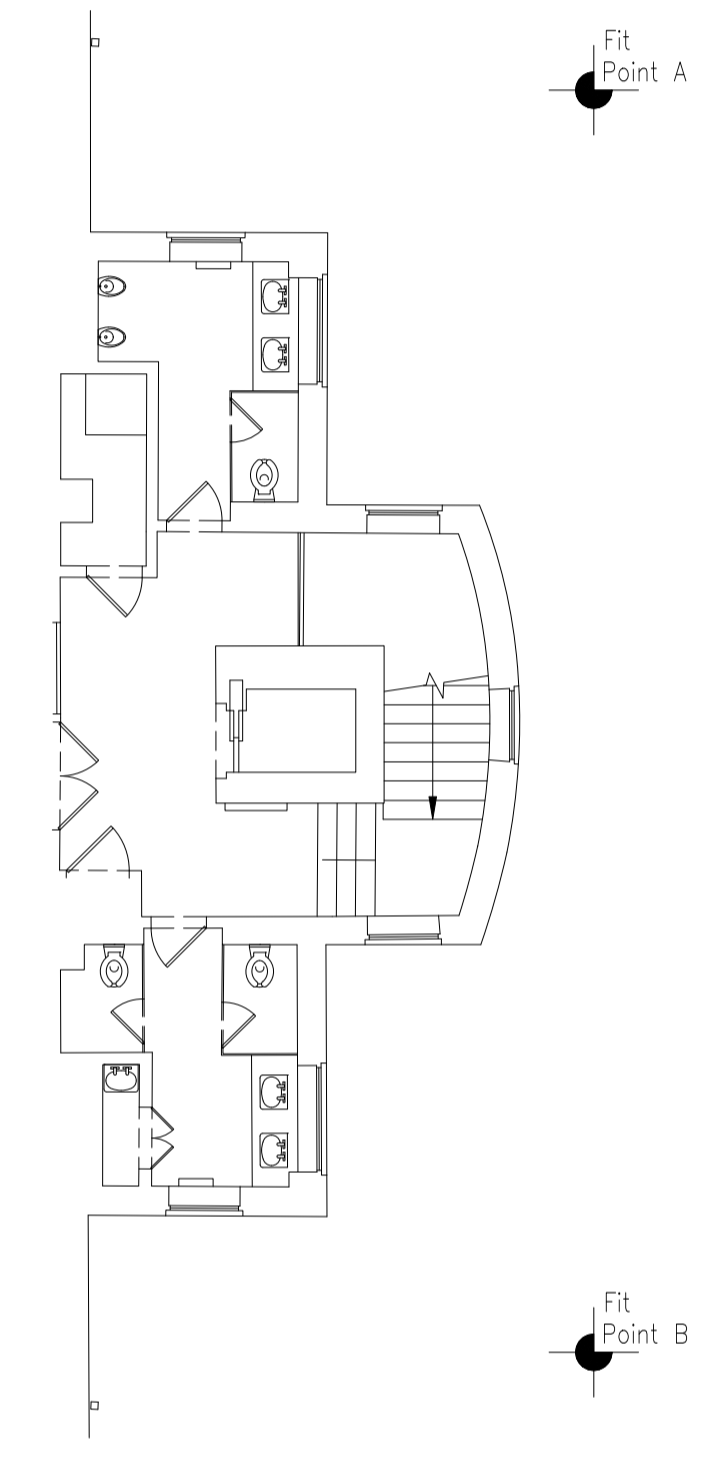

FIRST FLOOR PLAN

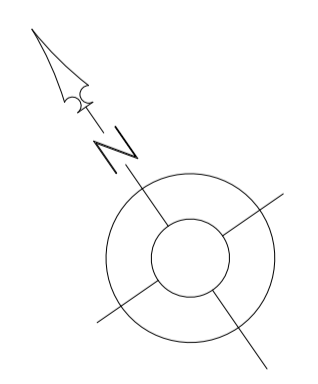


Legend:

Abbreviated Features:	Symbols:	Abbreviated Features:	Symbols:
AB Air Brick	LI Light	Radiator	⊞
B Balcony	O/F Overflow Pipe	Light	⊙
C/R Close Boarded	P Post	Emergency Light	⊕
C-H C/H to Head	P/C Pitched Ceiling	Stop Light	⊞
CL Chain Link	PE Pipe	Stop Light	⊞
CL Ceiling Level	P/R Pitched Roof	Wall Mounted Light	⊞
CPD Cupboard	P/W Post & Wire	Mains Point	⊞
CR Crown Point Level	RD Roller Door	Blank Plate	⊞
DH Door Height	RE Rodding Eye	Light Switch	⊞
Dr Drain	RWP R/Water Pipe	Pendant Switch	⊞
FE Fire Exit	SD Sliding Doors	Isolator Switch	⊞
F-C Floor to C/H	SS Suspended Ceiling Level	Isolator Switch	⊞
FL Floor Level	SP Spring Point Level	Alarm Bell	⊞
FW Four Water	SW Soil & Vent Pipe	Fire Alarm Push	⊞
MH Manhole	US Underside	Snow Detector	⊞
C Duty	UL Underside to Lift	Alarm Panel	⊞
IC Inspection Chamber	VP Vent Pipe	Thermostat	⊞
I Invert Level	VI Vent	Modes	⊞
I/R Iron Ratings		Fire Box	⊞
		Electric Box	⊞
		Heater	⊞
		Water Stop Tap	⊞
		Overhead Features	⊞


Plan Coordinate Control:-
N/A

Level Datum:-
All Levels relate to OSGB36 using GPS

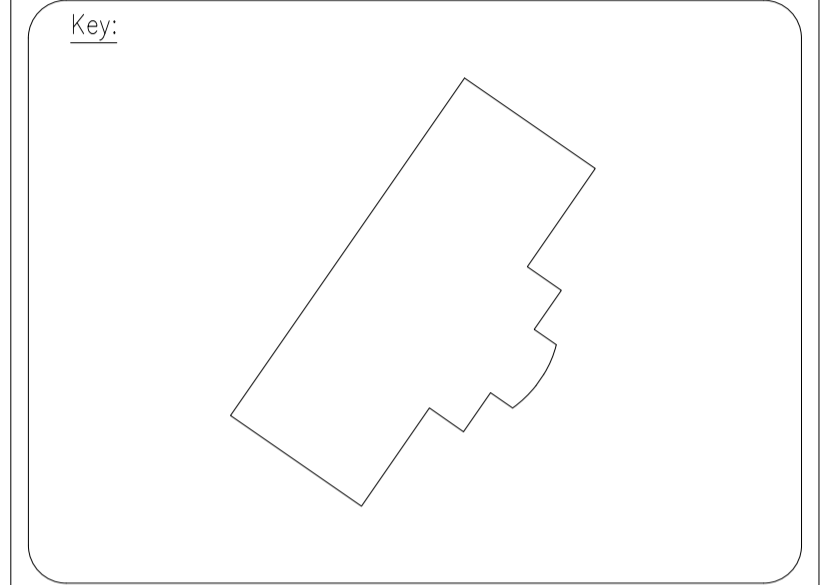

Notes:

REV NO	REV NOTE	DATE	SIGNED
REV A	Areas & dimensions added	07/03/25	SJH

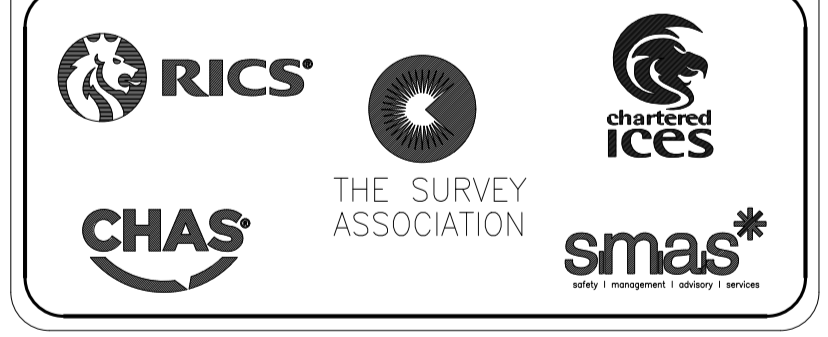

GLOBAL SURVEYS

3 Brookfield, Duncan Close,
Moulton Park, Northampton, NN3 6WL
Tel: 01604 491543
Email: info@globalsurveys.co.uk

Site: Radian Court
Knowlhill
Milton Keynes, MK5 8PJ

Client: Milton Keynes Parks Trust

Survey Title: Measured Building Survey
Ground & First Floor Plans

Date	February 2025	Scale	1/100 @ A1
Dwg No.	24706-MBS	Surveyor	EJ
Sheet	1 of 1	Checked	SJH