




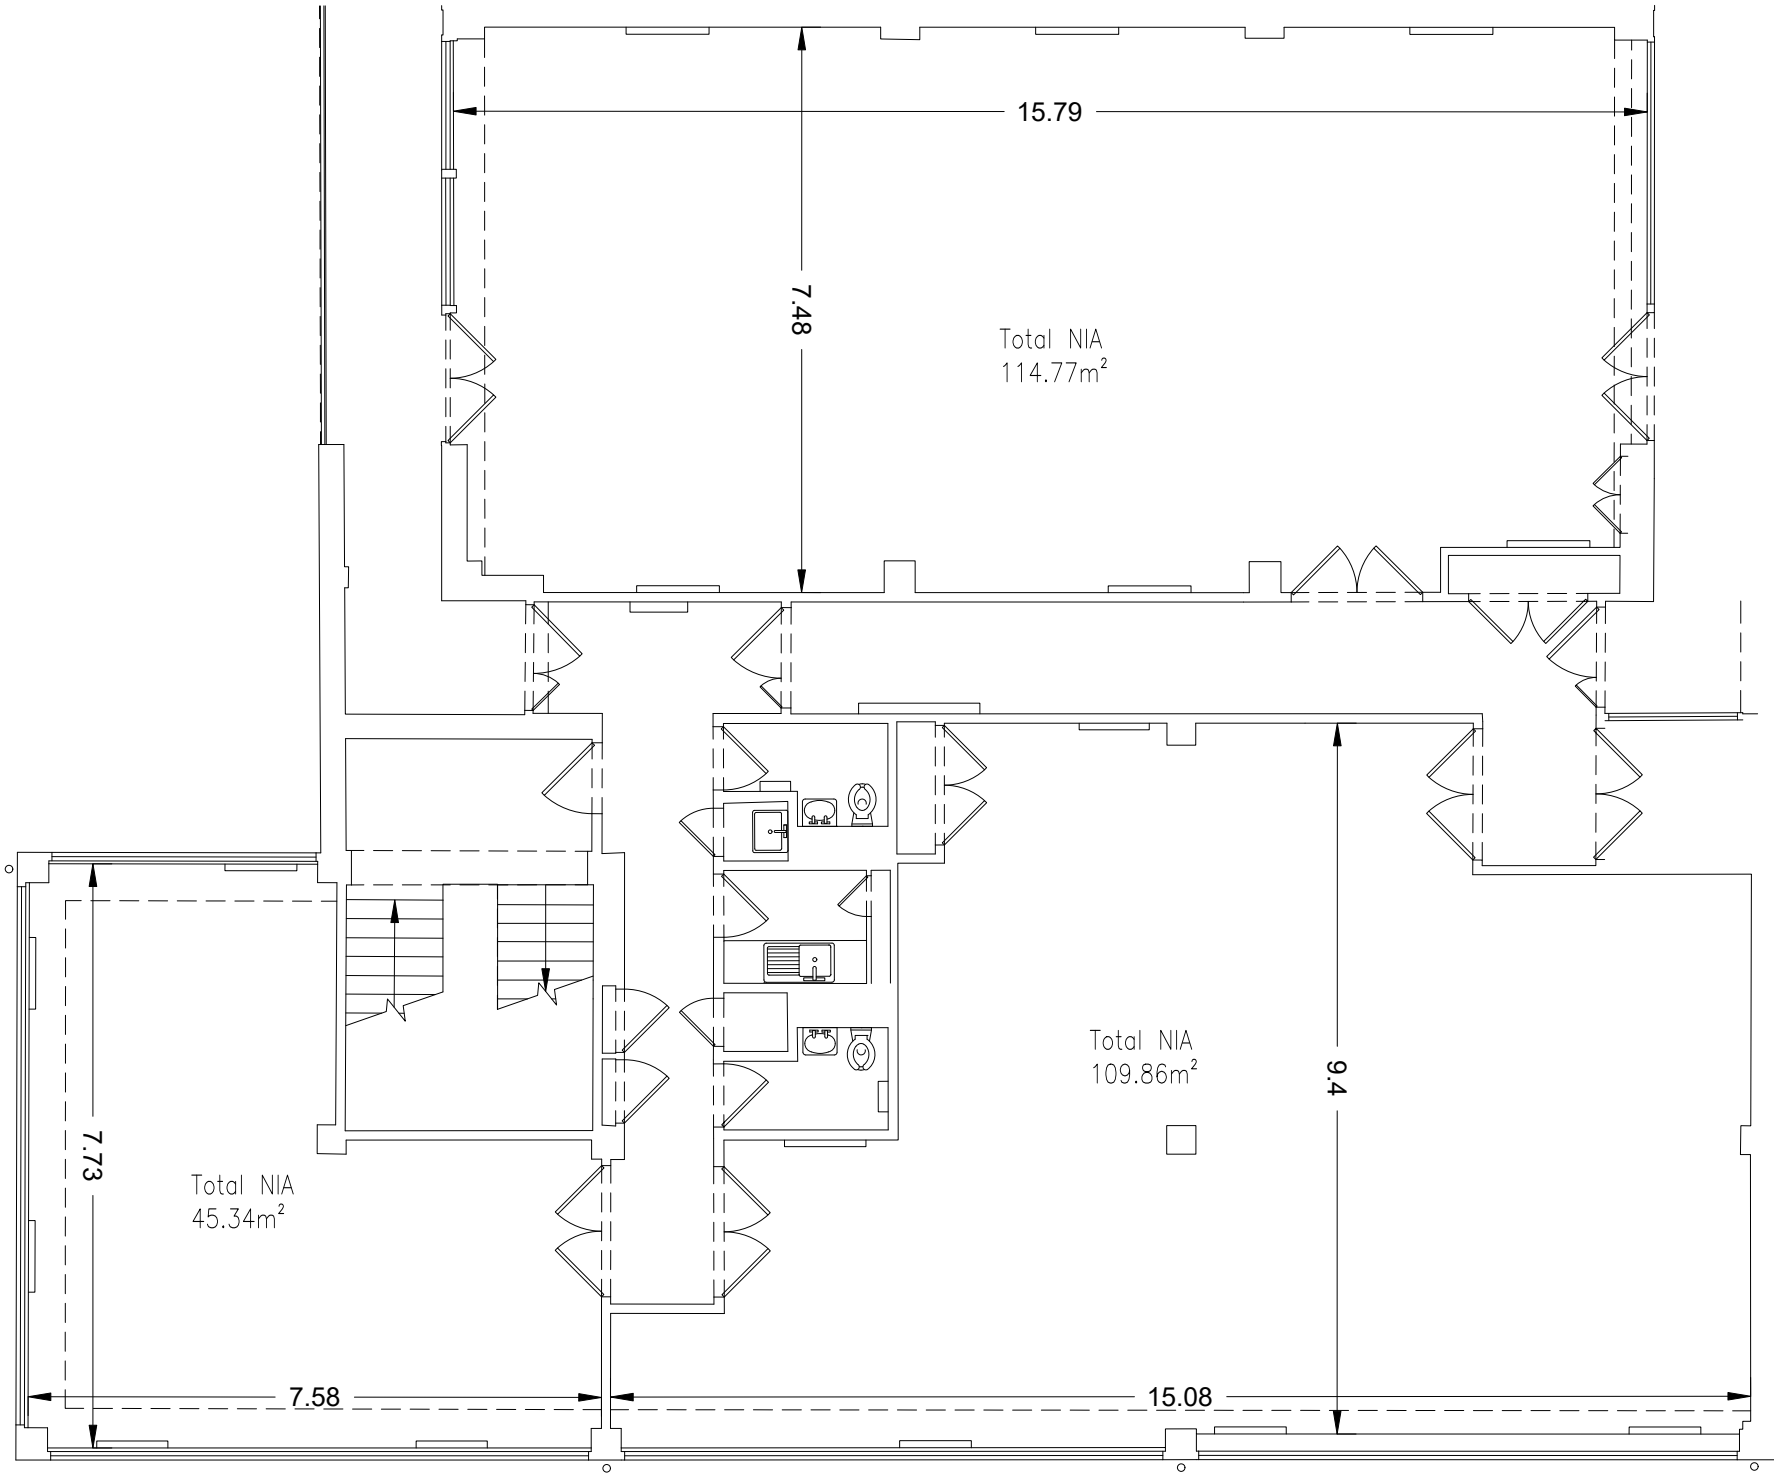

FIRST FLOOR PLAN

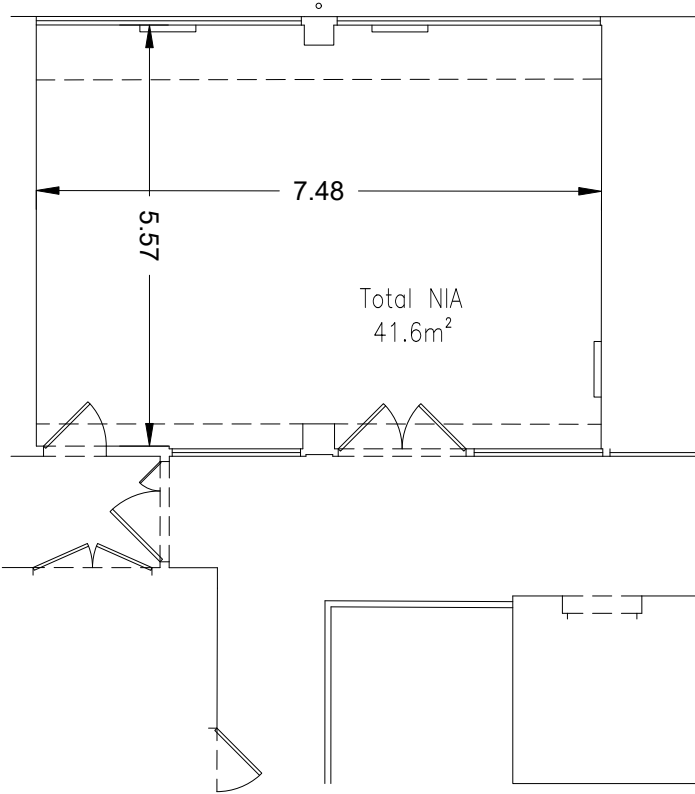

SECOND FLOOR PLAN

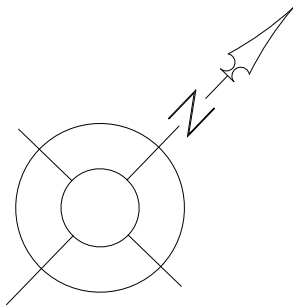

Legend:

Abbreviated Features:

AB

Air Brick

B

Bolard

C/B

Cable Banded

C-H

Cable to Head

C/L

Chain Link

CL

Ceiling Level

CPD

Cupboard

CR

Crown Point Level

DH

Door Height

Dr

Drain

FE

Fire Exit

F-C

Floor to Cill

FL

Floor Level

FW

Foul Water

MH

Manhole

U

Dully

C

Inspection Chamber

IL

Invert Level

I/R

Iron Railings

LI

Light

D/F

Overflow Pipe

P

Post

P/C

Pitched Ceiling

PS

Pipe

P/R

Pitched Roof

P/W

Post & Wire

RD

Roller Door

RNP

Rainwater Pipe

SD

Sliding Doors

SSL

Suspended Ceiling Level

SP

Spring Point Level

SW

Soil & Vent Pipe

US

Understore

UTL

Unstable To Lift

VP

Vent Pipe

VI

Vent

Radiator

Light

Light

Emergency Light

Strip Light

Wall Mounted Light

Mains Point

Blank Plate

Light Switch

Pendant Switch

Isolator Switch

Alarm Bell

Fire Alarm Push

Snow Detector

Alarm Panel

Thermotat

Modern

Fuse Box

Electric Box

Heater

Water Stop Tap

Overhead Features

Plan Coordinate Control:-

N/A

Level Datum:-

All Levels relate to OSGB36 using GPS

Key:

Notes:

A

Areas & room dimensions added

07/03/2025

GD

REV NO

REV

NOTE

DATE

SIGNED

3 Brookfield, Duncan Close,
Moulton Park, Northampton, NN3 6WL
Tel: 01604 491543
Email: info@globalsurveys.co.uk

Site:

Shenley Pavilions
Chalkdell Drive, Shenley Wood
Milton Keynes, MK5 6LB

Client:

Milton Keynes Parks Trust

Survey Title:

Measured Building Survey
First & Second Floor Plans

Date

February 2025

Scale

1/100

9 A1

Dwg No.

24707-MBS

Surveyor

GD

Sheet

2 of 2

Checked

SJH